 


PROJECT TITLE




세종문화회관

http://www.sejong.or.kr

세종문화회관  
시설현황도

NOTES

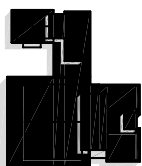

ARCHITECTS

CONSULTANTS  
STRUCTURAL

MECHANICAL

ELECTRICAL

Civil

REVISION	DESCRIPTION	DATE
REV. NO.	DESCRIPTION	DATE

APPROVED BY

REVIEWED BY

CHECKED BY

DRAWN BY

SCALE

DRAWING TITLE


지상2층 소화배관 확대 평면도  
(사무동)

DRAWING NO. F - 004

SHEET NO.

DATE 2024.10

 PROJECT TITLE




세종문화회관

http://www.sejong.or.kr

세종문화회관  
시설현황도

NOTES

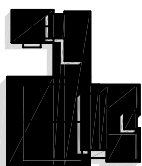

ARCHITECTS

CONSULTANTS  
STRUCTURAL

MECHANICAL

ELECTRICAL

Civil

REVISION	DESCRIPTION	DATE
REV. NO.	DESCRIPTION	DATE

APPROVED BY

REVIEWED BY

CHECKED BY

DRAWN BY

SCALE


DRAWING TITLE

지상2층 소화배관 확대 평면도  
(사무동)

DRAWING NO. F - 004


SHEET NO.

DATE 2024.10

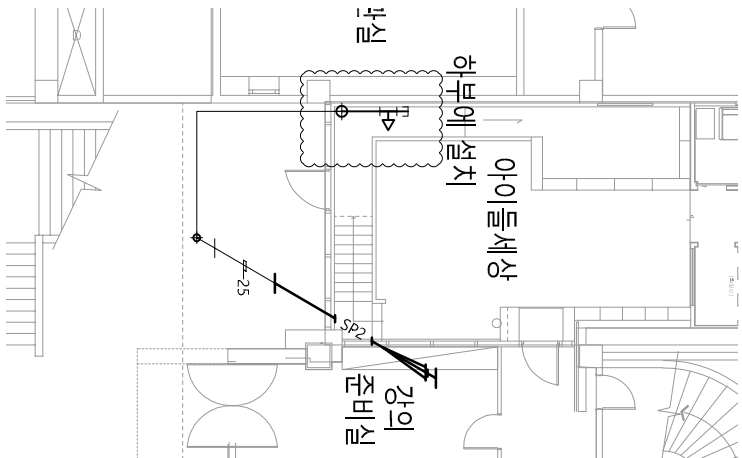

지상2층 하부 소화배관 확대 평면도

축척:A1(1/100), A3(1/200)

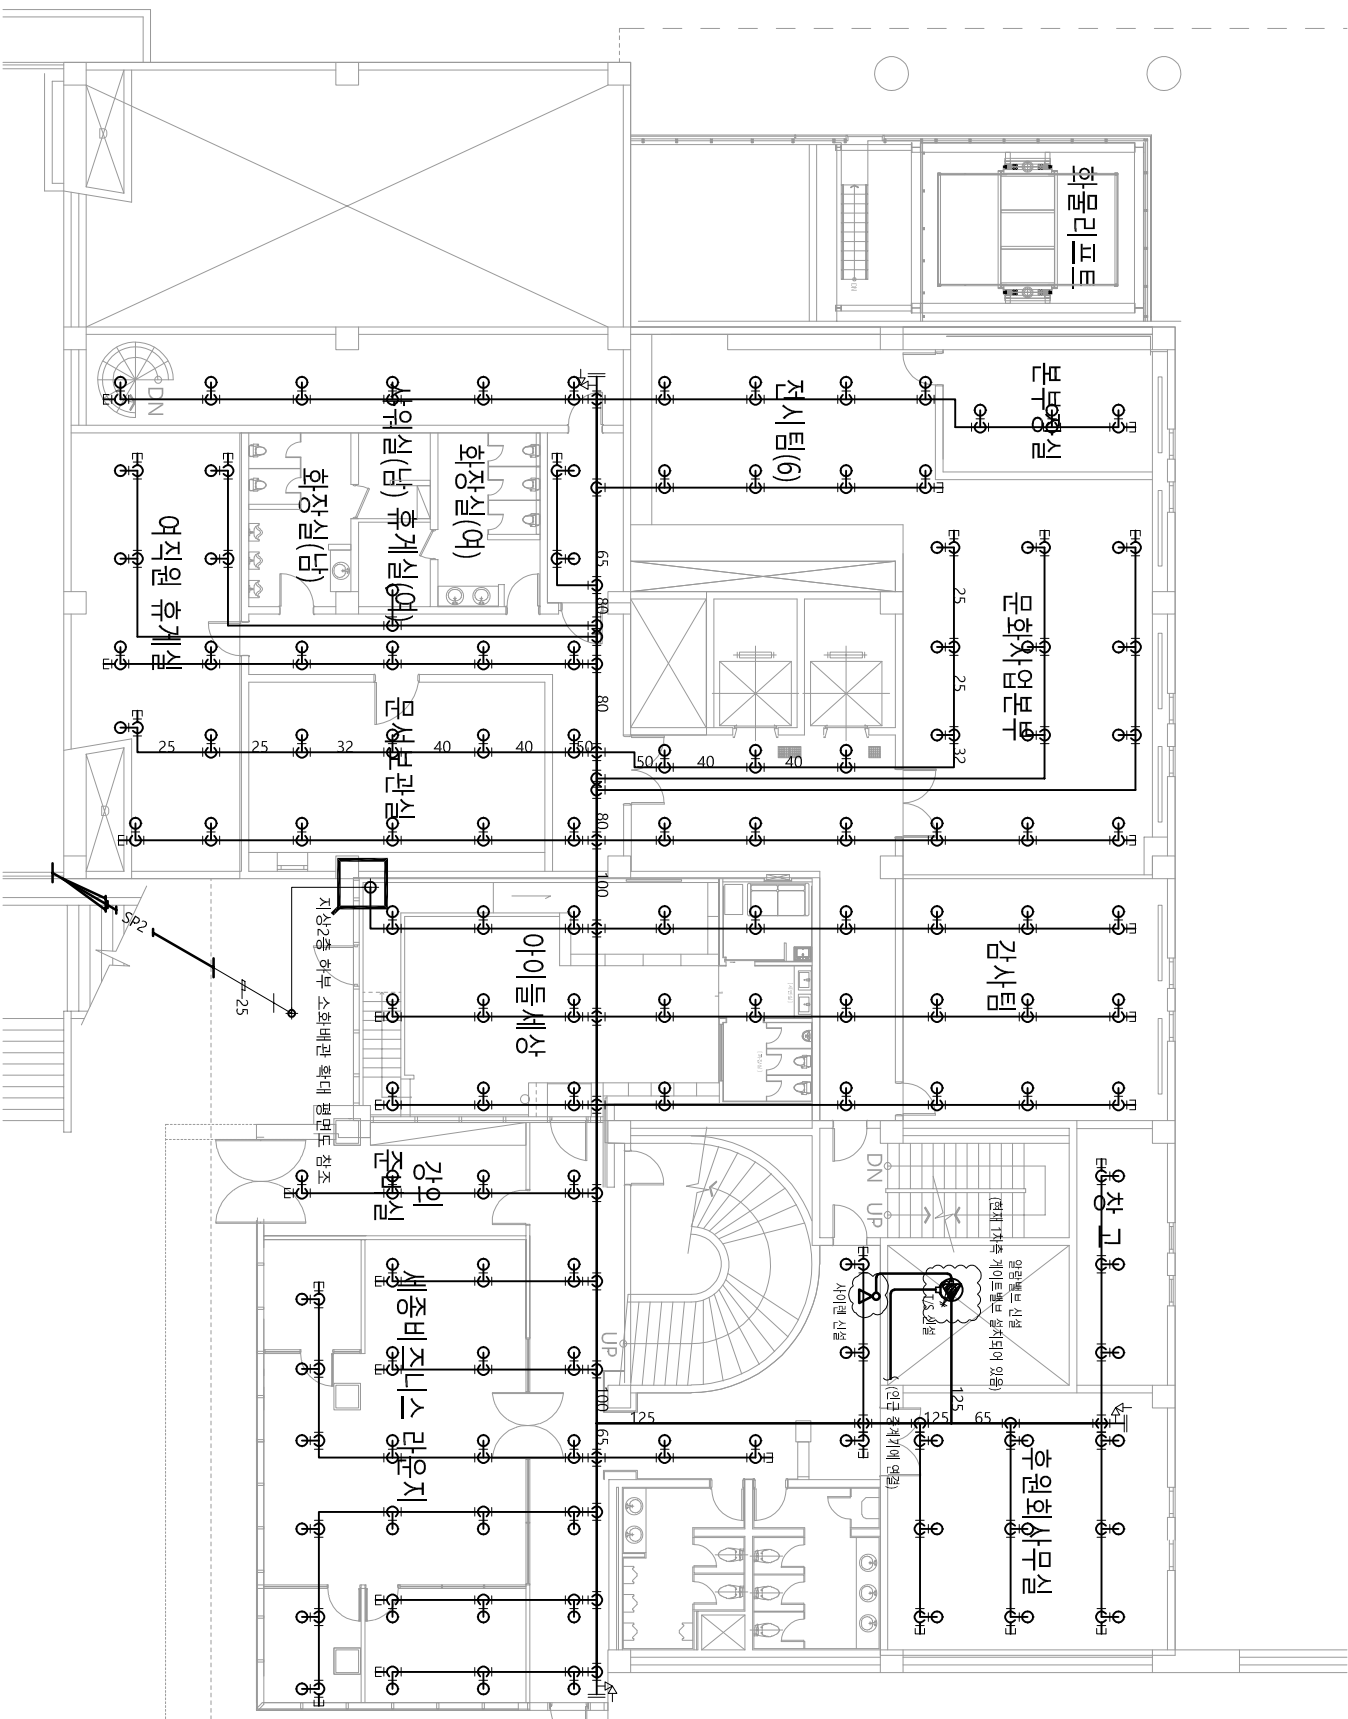

지상2층 소화배관 확대 평면도-사무동

축척:A1(1/100), A3(1/200)



(주) 정 평 이 앤 씨

일반소방시설 설계업 (전기, 기계)

면허번호 제 2023-01-00025 호

인천광역시 계양구 정제로 851, 5층

TEL : (032)547-7119, FAX : (032)548-7119

소방설비기사(전기, 기계)

대표이사

정경진

