


PROJECT TITLE

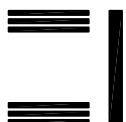


세종문화회관

http://www.sejong.ac.kr

세종문화회관  
시설현황도

NOTES

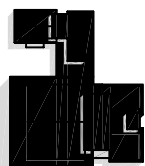

ARCHITECTS

CONSULTANTS  
STRUCTURAL

MECHANICAL

ELECTRICAL

Civil

REVISION	DESCRIPTION	DATE

APPROVED BY

REVIEWED BY

CHECKED BY

DRAWN BY

SCALE

DRAWING TITLE

지상2층 자동화제암시설비 평면도

DRAWING NO. F - 012

SHEET NO.

DATE 2024.10


6 7 XA1 XA2 XA3 XA4 XA5 XA6 13 14 15 16 17 18 18' 19

50700

43000

7000 2900 8200 10600 7200 7200 4800 2800 7000 7000 7000 7000 1000

세종예술통가세종예술통나세종예술통다

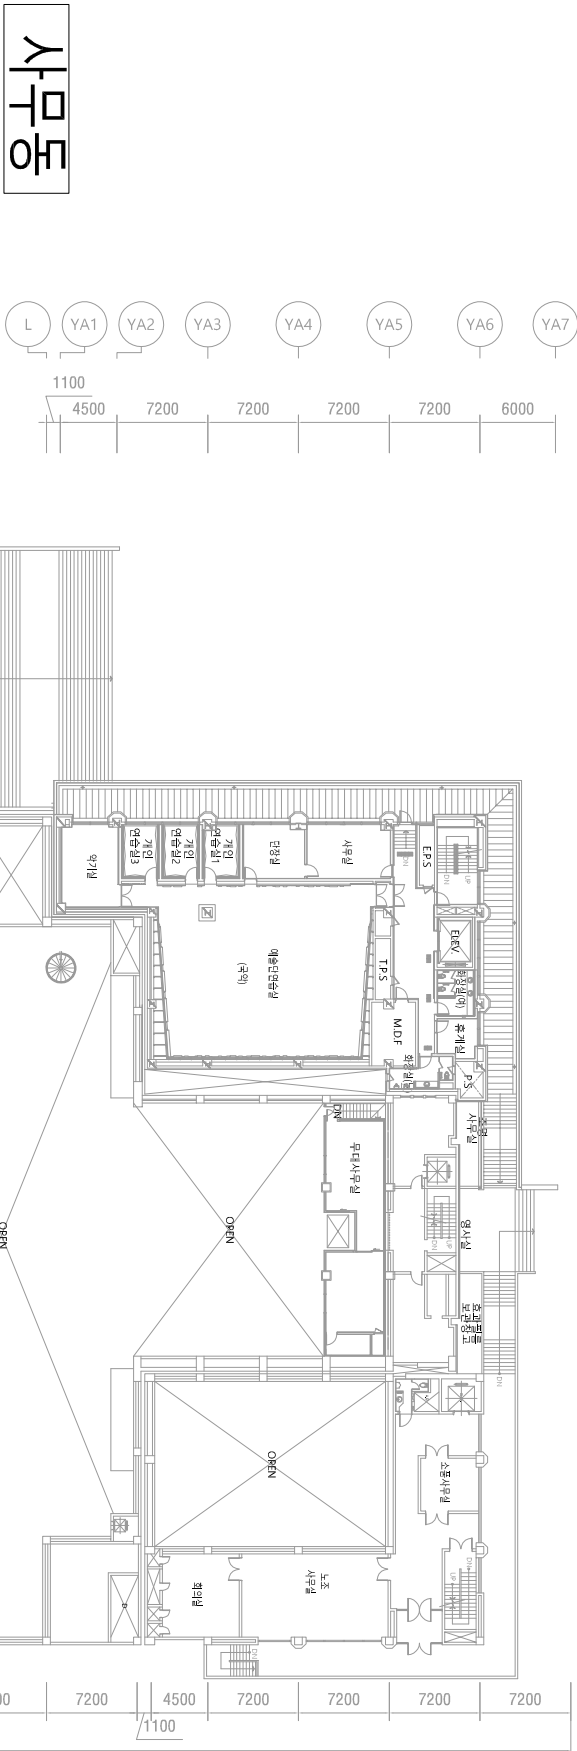

사무동

YA1 YA2 YA3 YA4 YA5 YA6 YA7  
1100 4500 7200 7200 7200 7200 6000

대극장

용역 범위

F-HFIX 1.6sq \* 4(16C)  
F-HFIX 1.6sq \* 8(22C)

배관 및 배선


심	불	명	정	수	량

심	불	명	정	수	량

범

레

1 지상2층 자동화제암시설비 평면도  
축척: A1(1/300), A3(1/600)

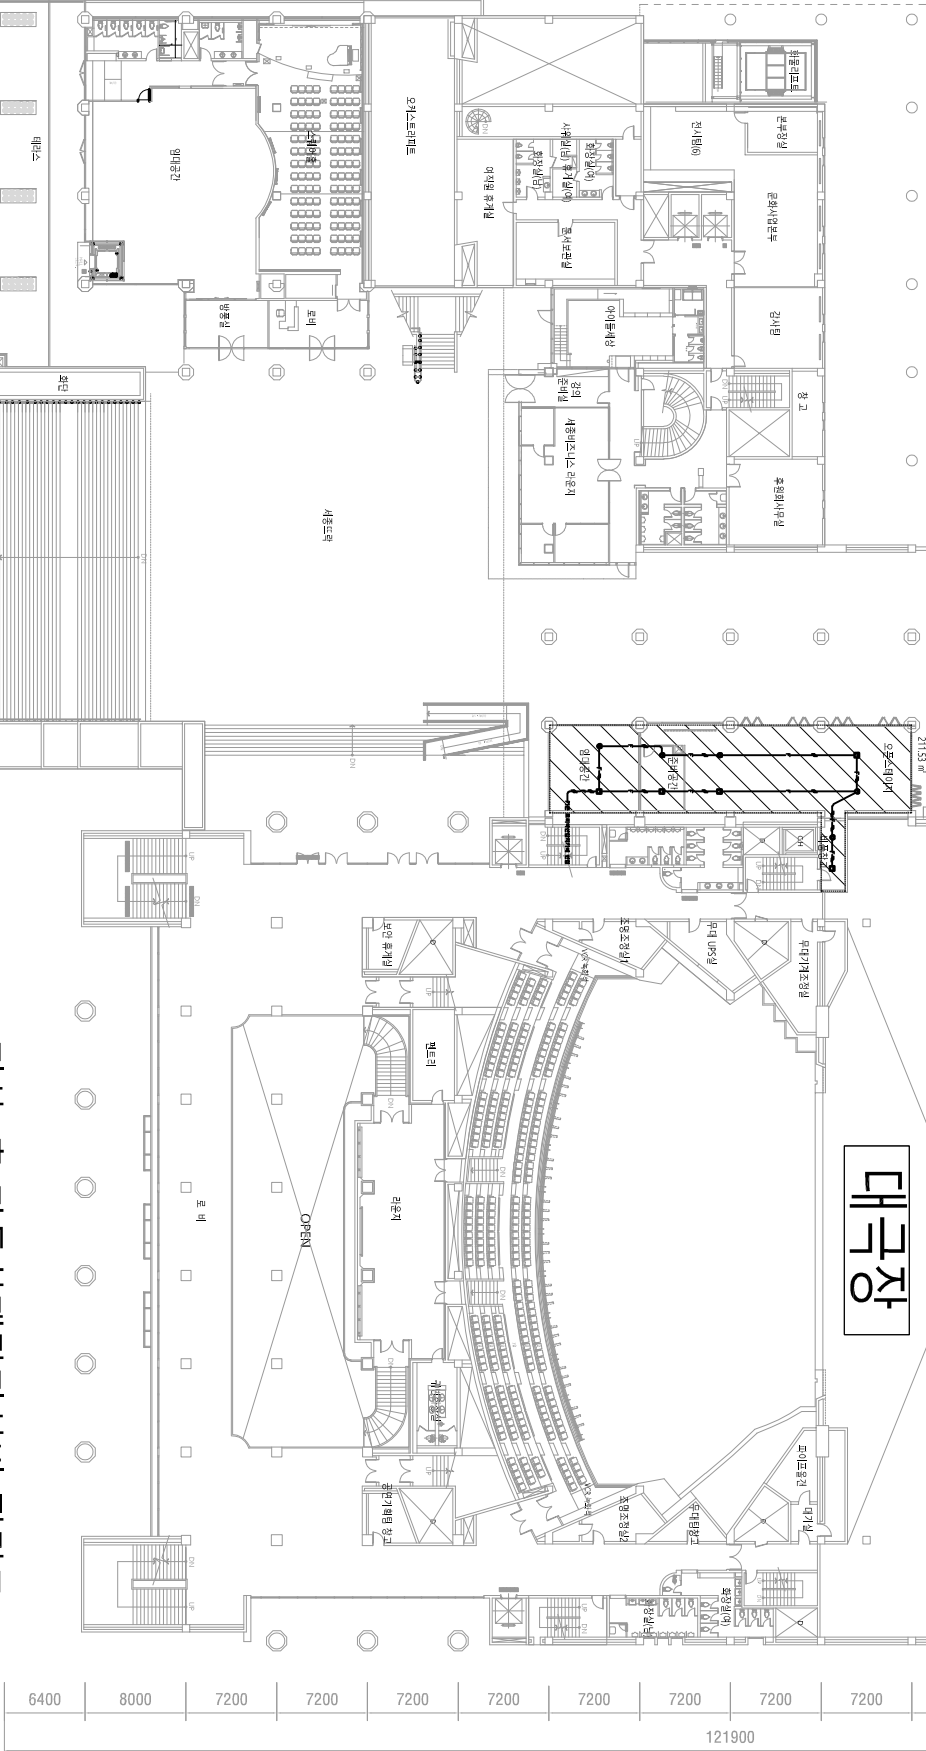

세종아카데미

7000 7000 7000 7000 7000 7000 7000 7000 7000 7700 8000 7000 7000 7000 7000 7000 7000 1000  
1 2 3 4 5 6 7 8 9 10 10' 11 12 13 14 15 16 17 18 18' 19